


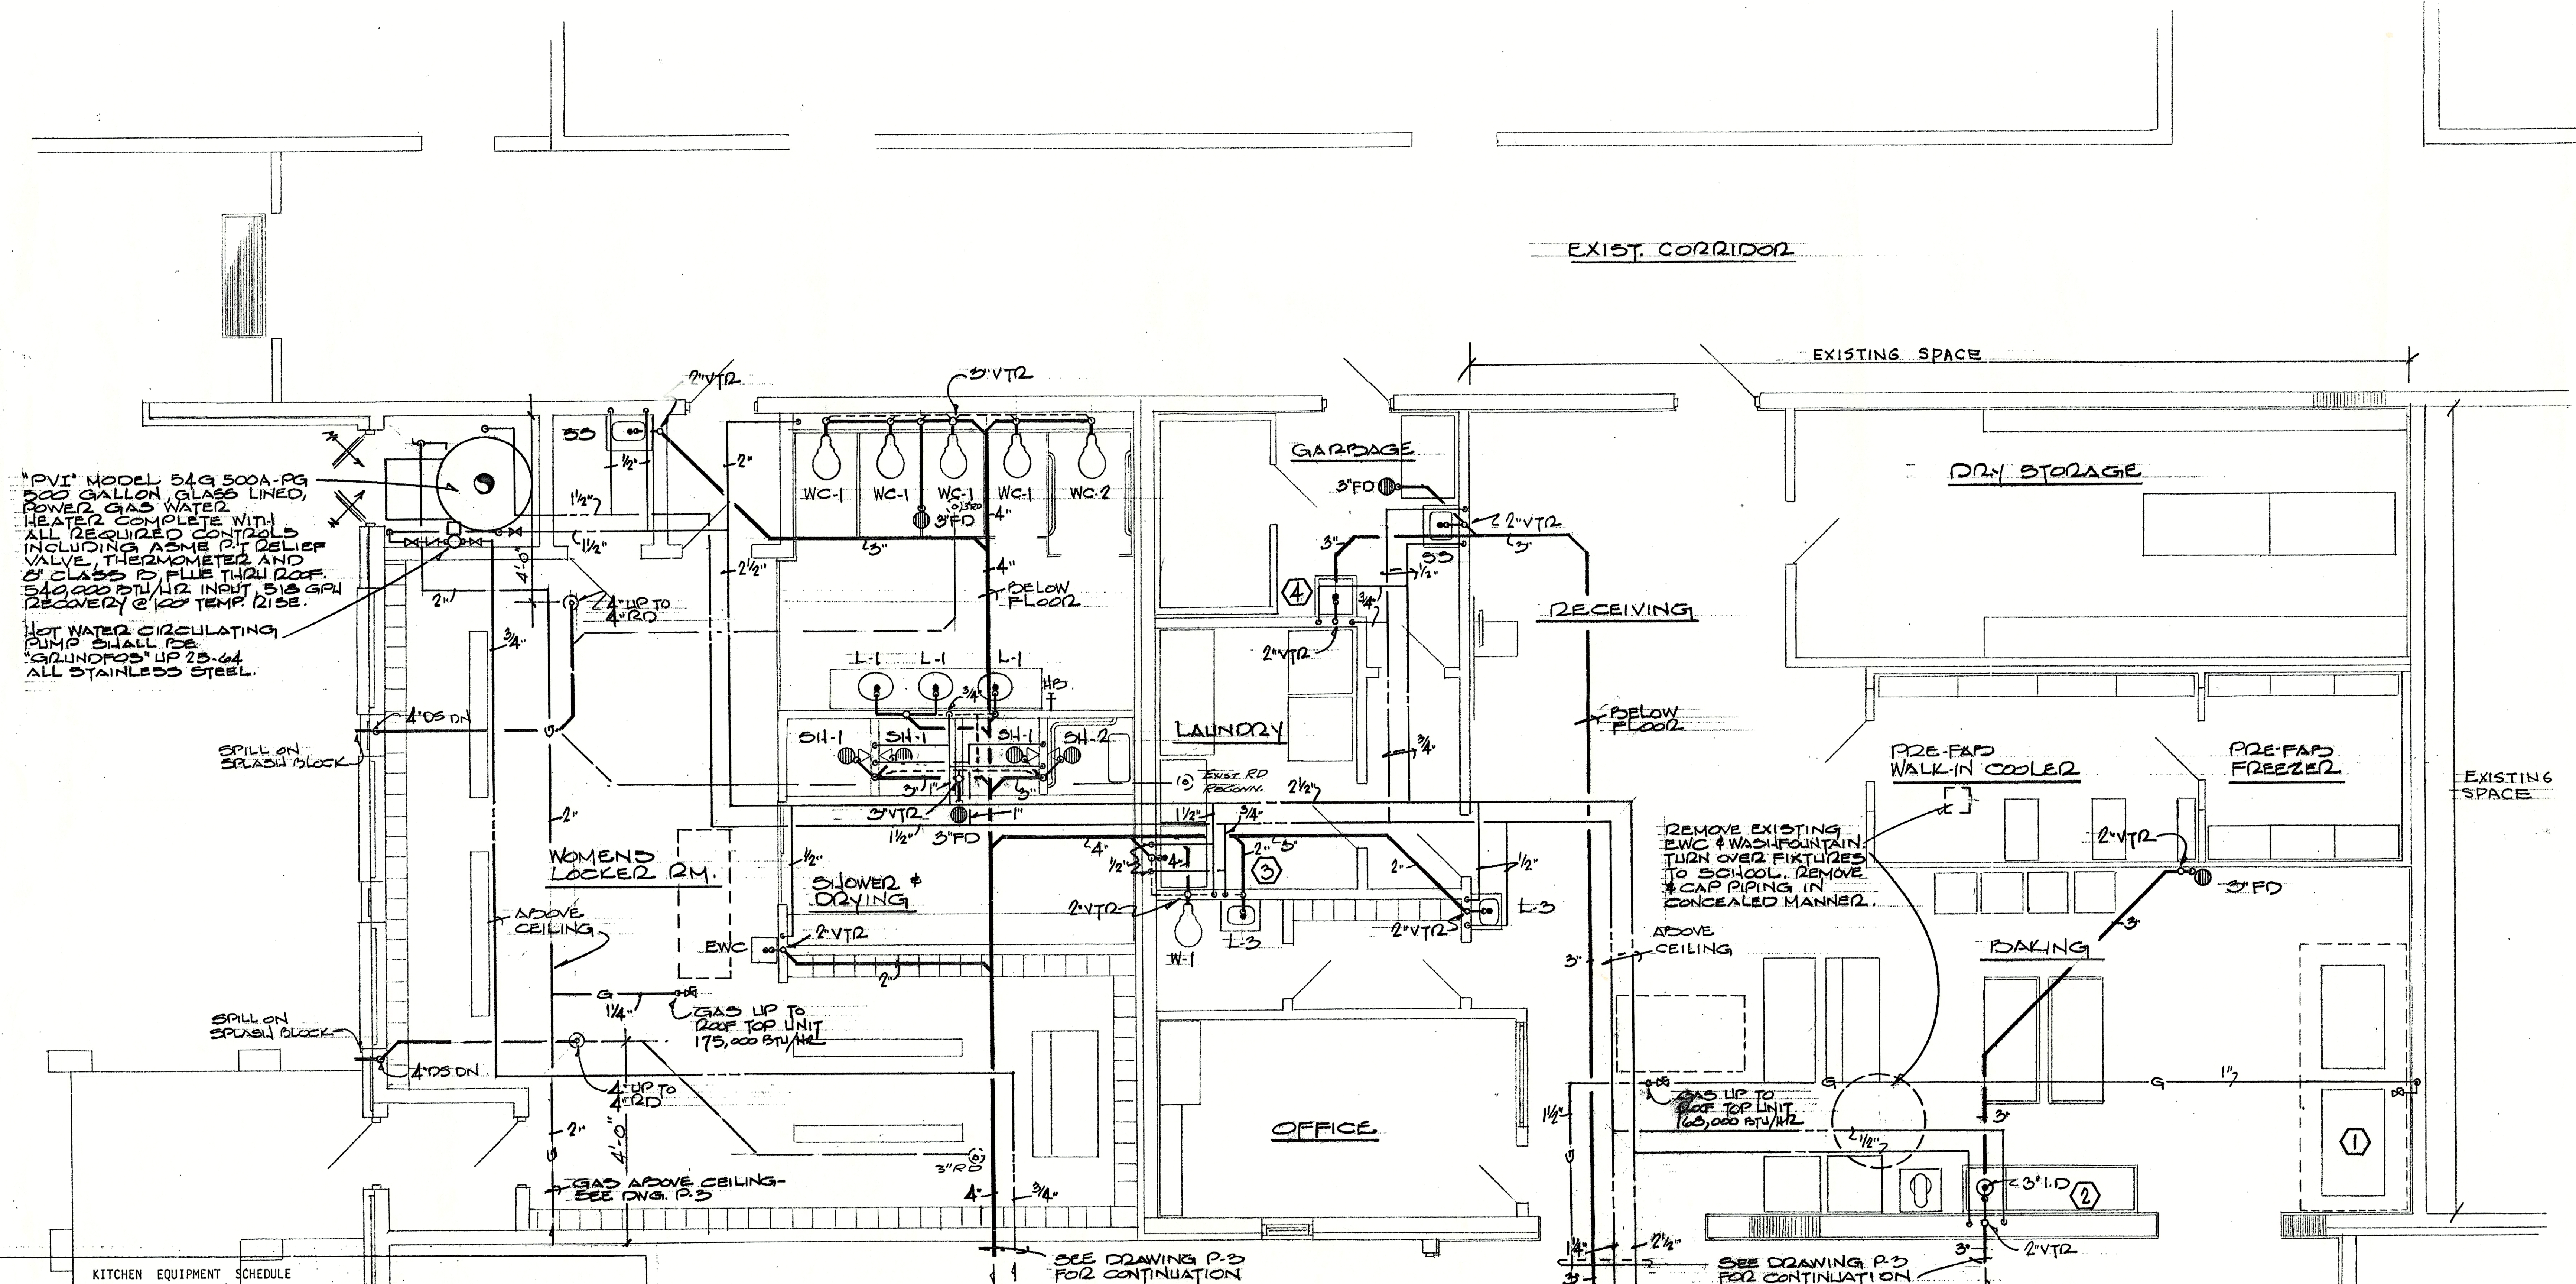

**FLOOR PLAN**  
SCALE: 1/4" = 1'-0"  
N

| KITCHEN EQUIPMENT SCHEDULE |                      |         |      |      |      |         |
|----------------------------|----------------------|---------|------|------|------|---------|
| ITEM #                     | DESCRIPTION          | WASTE   | C.W. | H.W. | GAS  | REMARKS |
| 1                          | PIE OVEN             | ---     | ---  | ---  | 3/4" | ---     |
| 2                          | WORK TABLE WITH SINK | 2"      | 1/2" | 1/2" | ---  | ---     |
| 3                          | WASHING MACHINE      | 2" I.D. | 1/2" | 1/2" | ---  | ---     |
| 4                          | CAN WASH             | 3"      | 1/2" | 1/2" | ---  | ---     |
| 5                          | CONVECTION OVEN      | ---     | ---  | ---  | ---  | ---     |
| 6                          | ROASTING OVEN        | ---     | ---  | ---  | ---  | ---     |
| 7                          | STEAM COOKER         | ---     | ---  | ---  | ---  | ---     |
| 8                          | DEEP FAN FRYER       | ---     | ---  | ---  | ---  | ---     |
| 9                          | RANGE                | ---     | ---  | ---  | ---  | ---     |
| 10                         | SALAD SINK           | 2"      | 1/2" | 1/2" | ---  | ---     |
| 11                         | RINSING SINK         | 2"      | 1/2" | 1/2" | ---  | ---     |
| 12                         | DISHWASHER           | 2"      | ---  | 1/2" | ---  | ---     |
| 13                         | POT SINK             | 2"      | 1/2" | 1/2" | ---  | ---     |
| 14                         | HOT WATER BOOSTER    | ---     | ---  | 3/4" | ---  | ---     |
| 15                         | ICE CUBE MACHINE     | TO I.D. | 1/2" | ---  | ---  | ---     |
| 16                         | WAITRESS STATION     | TO I.D. | 1/2" | 1/2" | ---  | ---     |
| 17                         | SINK                 | 2"      | 1/2" | 1/2" | ---  | ---     |
| 18                         | DISPOSAL             | 2"      | 1"   | ---  | ---  | ---     |

GAS CONNECTIONS FROM MANIFOLD BEHIND EQUIPMENT.

3/4" 180° HW FROM BOOSTER

**FOOD SERVICE &  
BLDG. B SUPPORT FACIL.**

P.2  
OF  
10

Tilden Denson & Lobnitz, Inc.  
Consulting Engineers  
940 Highland Ave. Ph. 841-9050  
ORLANDO, FLORIDA 32803